


1-01 PLUMBING DETAIL ELEVATION
NO SCALE


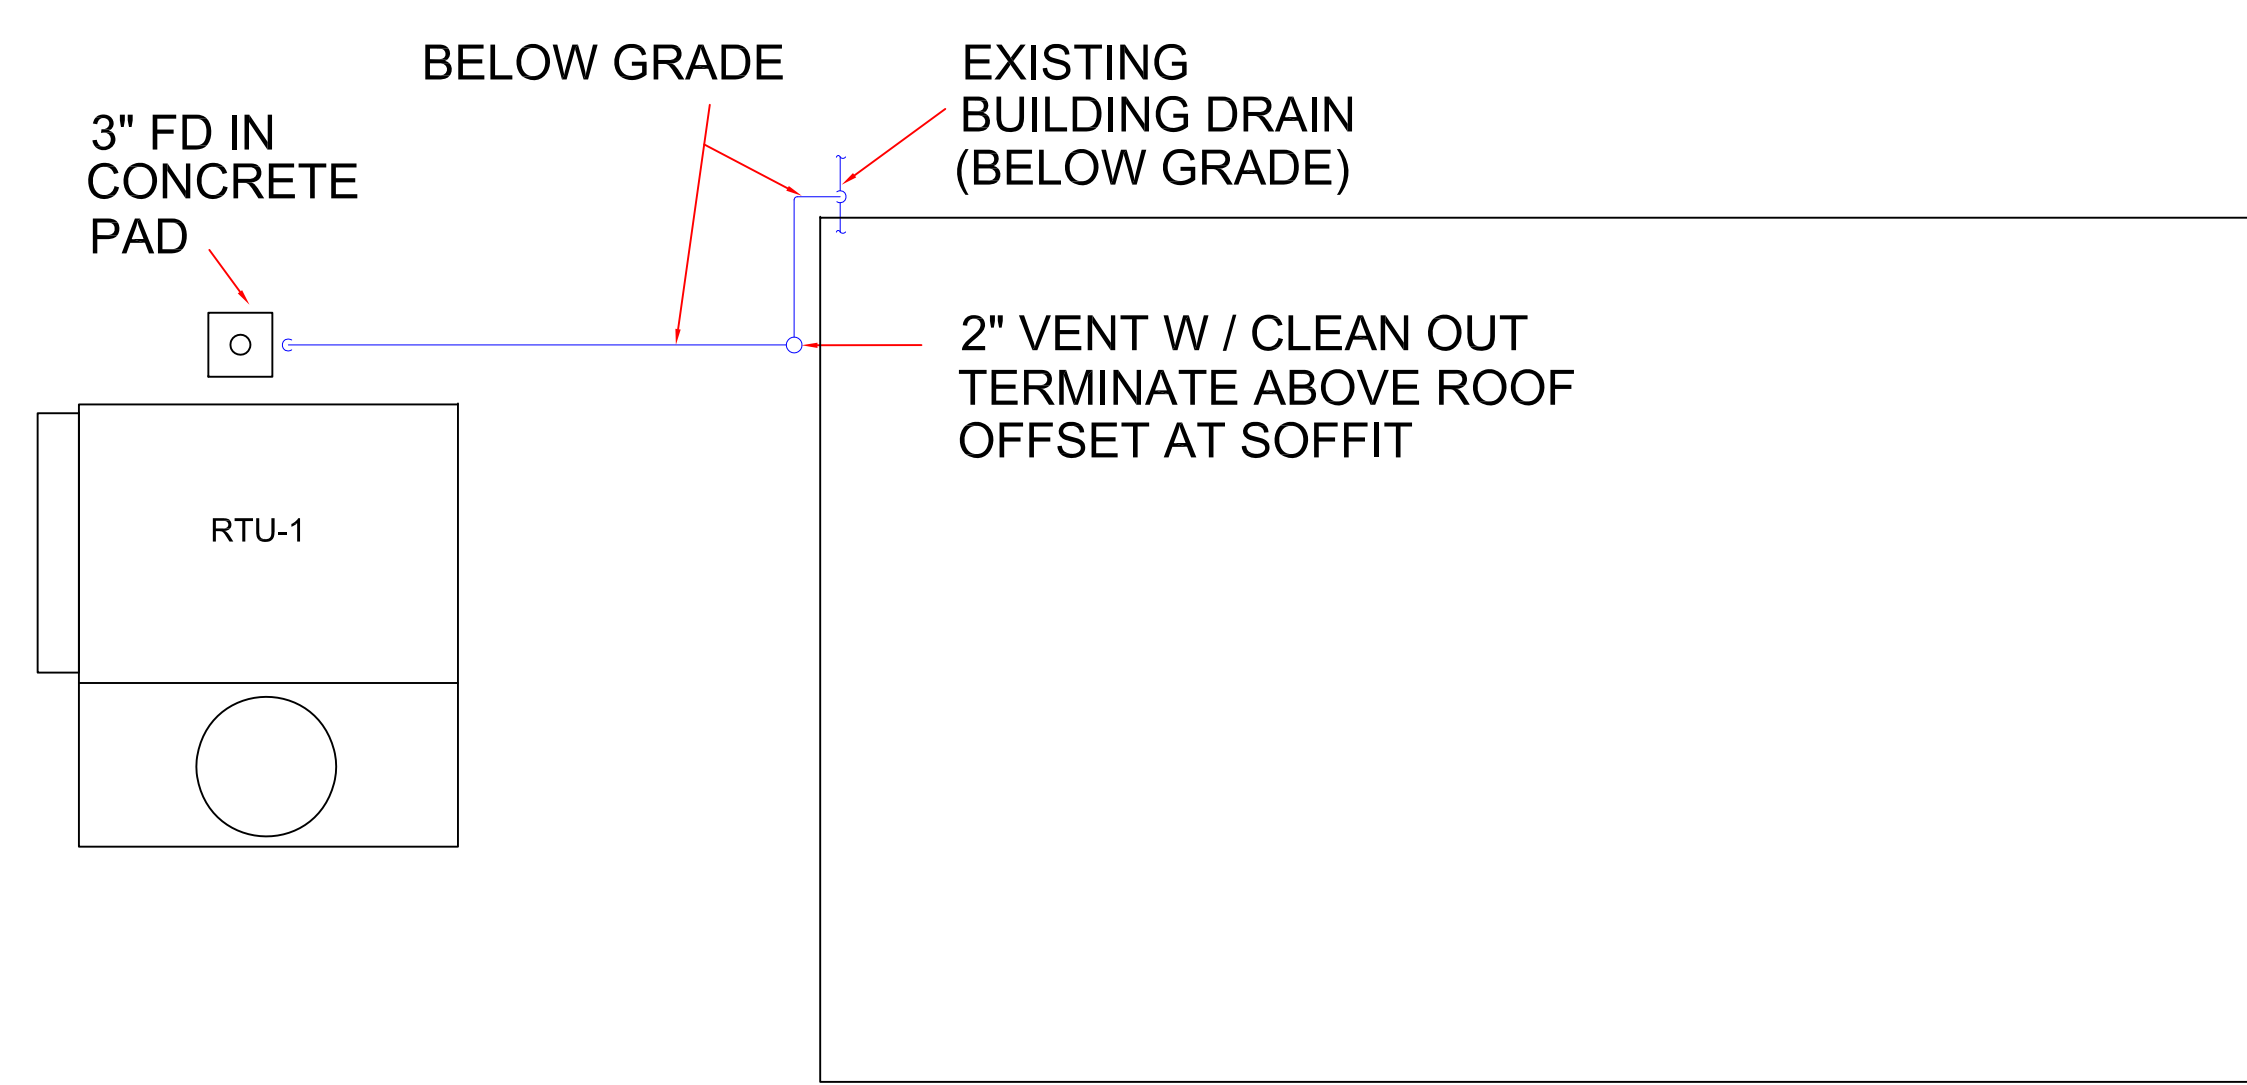


1-02 PLUMBING DETAIL PLAN
1/4" = 1'-0"

- PLUMBING NOTES:
1. DRAWINGS OMIT MANY EXISTING ITEMS FOR BREVITY AND CLARITY.
 2. DRAWINGS ARE DIAGRAMTIC IN NATURE. ACTUAL INSTALLATION MAY REQUIRE ADDITIONAL OFFSETS OR FITTINGS.
 3. DRAWINGS MAY CONTAIN INACCURACIES RELATING TO EXISTING CONDITIONS. REPORT SUCH TO ENGINEER.
 4. VERIFY SIZES OF EXISTING ITEMS AT POINTS OF CONNECTION TO NEW WORK. REPORT DEVIATIONS TO ENGINEER.
 5. ALL PIPE AND FITTINGS SHALL BE MANUFACTURED IN THE USA.
 6. SANITARY WASTE AND VENT PIPE SHALL BE SERVICE WEIGHT HUB AND SPIGOT CAST IRON SOIL PIPE AND FITTINGS ASTM A 74 WITH RUBBER GASKETS ASTM C 564.
 7. SUPPORT PIPE IN ACCORDANCE WITH MANUFACTURERS STANDARDIZATION SOCIETY STANDARDS FOR SUPPORTING PIPES FOR THE TYPES AND SIZES OF PIPES BEING INSTALLED.
 8. FLOOR DRAIN SHALL BE SIMILAR TO WATTS FD-200-EF WITH NICKEL BRONZE STRAINER AND NICKEL BRONZE FUNNEL.
 9. LABEL NEW PIPE IN ACCORDANCE WITH ANSI/ASME STANDARD A13.1 IDENTIFICATION OF PIPING SYSTEMS. SPACE LABELS NOT MORE THAN 10 FEET APART ON EACH RUN OF PIPE.
 10. PROVIDE SUBMITTALS FOR NEW PLUMBING FIXTURES.
 11. ALL WORK SHALL BE IN ACCORDANCE WITH IBC, IPC, NFPA 101 AND APPLICABLE LAWS, REGULATIONS AND CODES.

SSC services for education

TEXAS REGISTRATION P-14276
ENGINEERING DESIGN AND CONSTRUCTION SERVICES
COLLEGE STATION, TX 77843-1371
(979) 845-5317 FAX: (979) 862-1661

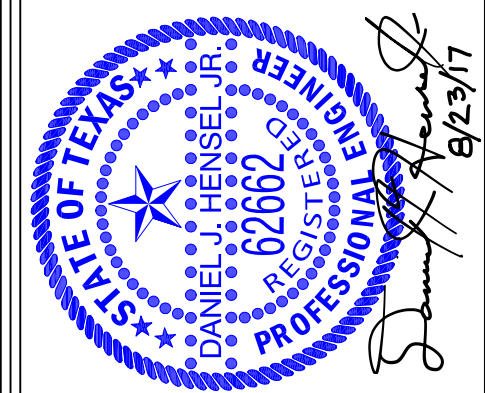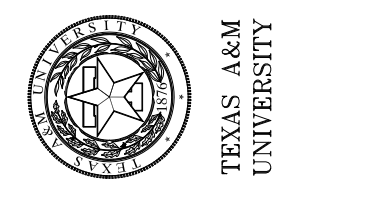

PLUMBING
DETAIL

REPLACE HEATING AND
COOLING SYSTEMS
VET ISOLATION BUILDING
#1220-1228
PROJECT # 2016-01086

WORK ORDER NO.: _____
PROJECT NO.: 2016 - 01086
PROJECT MANAGER: JAVIER SANTOS
DRAWN BY: FARSHID MOOSAVI
DATE ISSUED: 08/23/2017