


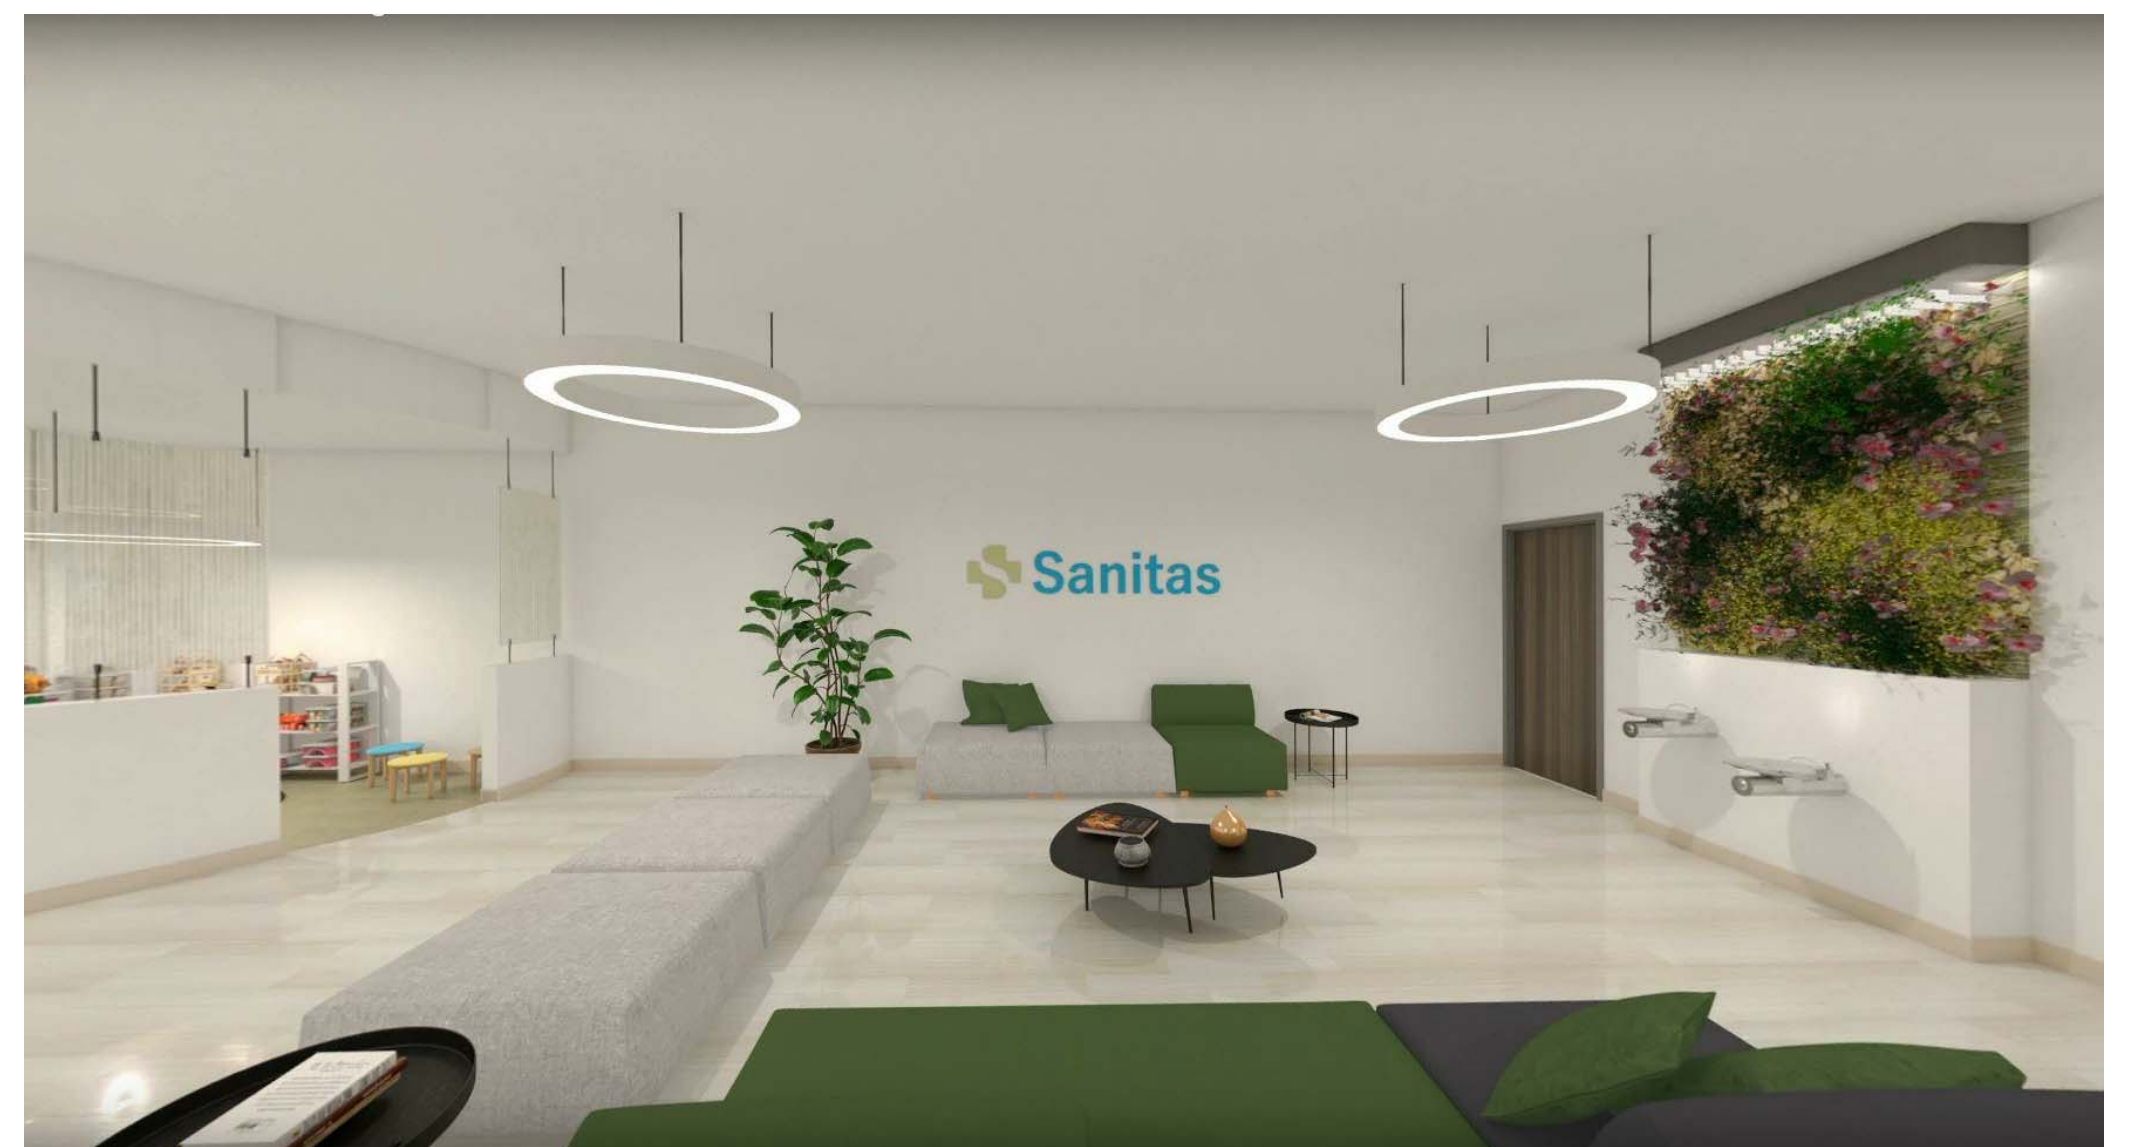

**SANITAS AREA #1**  
12520 Westheimer RD., Houston, TX 77077

**INDEX**

#	Sheet Number	Sheet Name	Current Revision	Current Revision Date
1	A000	COVER SHEET	2	05/13/2019
2	A001	PROJECT INFORMATION		
3	A002	SITE PLAN		
4	A003	LEAD LINE WALL		
5	AD100	DEMOLITION PLAN		
6	A100	SAFETY PLAN		
7	A101	MAIN FLOOR PLAN		
8	A102	REFLECTED CEILING PLAN		
9	A103	FLOOR FINISHES		
10	A104	FINISH SCHEDULE		
11	A105	WALL FINISHES		
12	A106	WALL FINISHES SCHEDULE		
13	A300	SECTIONS		
14	A400	ACCESSORIES & FIXTURES (STANDARD HEIGHTS)		
15	A401	WALL SECTIONS & DETAILS		
16	A500	ENLARGED PLAN AND INTERIOR ELEVATIONS 1.0		
17	A501	INTERIOR ELEVATIONS 1.0		
18	A502	INTERIOR ELEVATIONS 1.0		
19	A503	INTERIOR ELEVATIONS 1.0		
20	A504	ENLARGED PLAN AND INTERIOR ELEVATIONS 2.0		
21	A505	INTERIOR ELEVATIONS 2.0		
22	A506	INTERIOR ELEVATIONS 2.0		
23	A507	ENLARGED PLAN AND INTERIOR ELEVATIONS 3.0		
24	A508	INTERIOR ELEVATIONS 3.0		
25	A509	INTERIOR ELEVATIONS 3.0		
26	A510	INTERIOR ELEVATIONS 3.0		
27	A511	ENLARGED PLAN AND INTERIOR ELEVATIONS 4.0		
28	A512	INTERIOR ELEVATIONS 4.0		
29	A513	INTERIOR ELEVATIONS 4.0		
30	A514	ENLARGED PLAN AND INTERIOR ELEVATIONS 5.0		
31	A515	INTERIOR ELEVATIONS 5.0		
32	A516	INTERIOR ELEVATIONS 5.0		
33	A517	INTERIOR ELEVATIONS 5.0		
34	A518	ENLARGED PLAN AND INTERIOR ELEVATIONS 6.0		
35	A519	INTERIOR ELEVATIONS 6.0		
36	A520	INTERIOR ELEVATIONS 6.0		
37	A521	INTERIOR ELEVATIONS 6.0		
38	A522	ENLARGED PLAN AND INTERIOR ELEVATIONS 7.0		
39	A523	INTERIOR ELEVATIONS 7.0		
40	A524	INTERIOR ELEVATIONS 7.0		
41	A525	ENLARGED PLAN AND INTERIOR ELEVATIONS 8.0		
42	A526	INTERIOR ELEVATIONS 8.0		
43	A527	INTERIOR ELEVATIONS 8.0		
44	A528	INTERIOR ELEVATIONS 8.0		
45	A600	DOOR SCHEDULE & DETAILS		
46	A601	DOOR HARDWARE DESCRIPTION		
47	E100	ELECTRICAL PLAN		
48	E200	LIGHTING FIXTURES PLAN		
49	D100	FRP @ WORKSTATIONS		
50	D101	CORNER GUARDS & WALL PROTECTORS		
51	D102	EQUIPMENT & LOCATIONS		
53	D200	MILLWORK - REFERENCE PLAN		
54	D201	MILLWORK 1.0		
55	D202	MILLWORK 2.0		
56	D203	MILLWORK 3.0		
57	D204	MILLWORK 4.0		
58	D205	MILLWORK 5.0		
59	D206	MILLWORK 6.0		
60	D207	MILLWORK 7.0		
61	D208	MILLWORK 8.0		



<b>PROGRAMED BY:</b> 	<b>EXECUTIVE ARCHITECT:</b> DANIEL G. PEREZ 	<b>ARCHITECT OF RECORD</b>  SEAL	<b>DEVELOPER</b> HCSC SANITAS  <b>DATE:</b> 05/10/2019  <b>REMARKS</b> CONSTRUCTION DOCUMENTS	<b>MODIFICATIONS :</b>	<b>CONTAINS:</b>																													
				<table border="1"> <thead> <tr> <th>No.</th> <th>DATE</th> <th>DESCRIPTION</th> </tr> </thead> <tbody> <tr><td> </td><td> </td><td> </td></tr> <tr><td> </td><td> </td><td> </td></tr> <tr><td> </td><td> </td><td> </td></tr> <tr><td> </td><td> </td><td> </td></tr> <tr><td> </td><td> </td><td> </td></tr> <tr><td> </td><td> </td><td> </td></tr> <tr><td> </td><td> </td><td> </td></tr> <tr><td> </td><td> </td><td> </td></tr> <tr><td> </td><td> </td><td> </td></tr> <tr><td> </td><td> </td><td> </td></tr> </tbody> </table>	No.	DATE	DESCRIPTION																											
No.	DATE	DESCRIPTION																																
<b>PROJECT</b> Sanitas Westheimer  12520 Westheimer RD. Houston, TX 77077	<b>ENGINEERS</b> 