



JOHNSTON

2803 Augusta Drive, Suite 1500  
Houston, TX 77057  
713.244.8300  
www.johnstonllc.com

CLIENT:

HOUSTON  
**Methodist**  
WILLOWBROOK HOSPITAL

STRUCTURAL

WALTER P MOORE

MEP




TECHNOLOGY



PROJECT TITLE:

HMWH  
HARGRAVE-NP  
SKYBRIDGE  
PACKAGE 2

PLAN KEY:

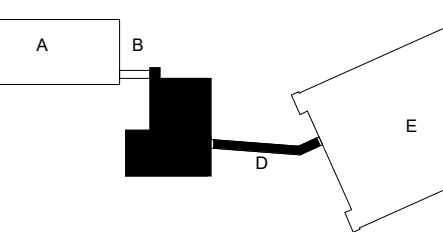

PROFESSIONAL SEAL:



2019 08 21

PROJECT SUBMISSION:  
ADDENDUM NO. 1

DATE: 2019 08 21

NO. REVISION/ISSUE YYYY MM DD

1 ADDENDUM #01 08/21/2019

PROJECT NO: 19-00004-00


DRAWN BY: JOHNSTON

SHEET TITLE:


MECHANICAL PLAN -  
LEVEL 3 - AREA C  
& D

SHEET:


M2.03CD

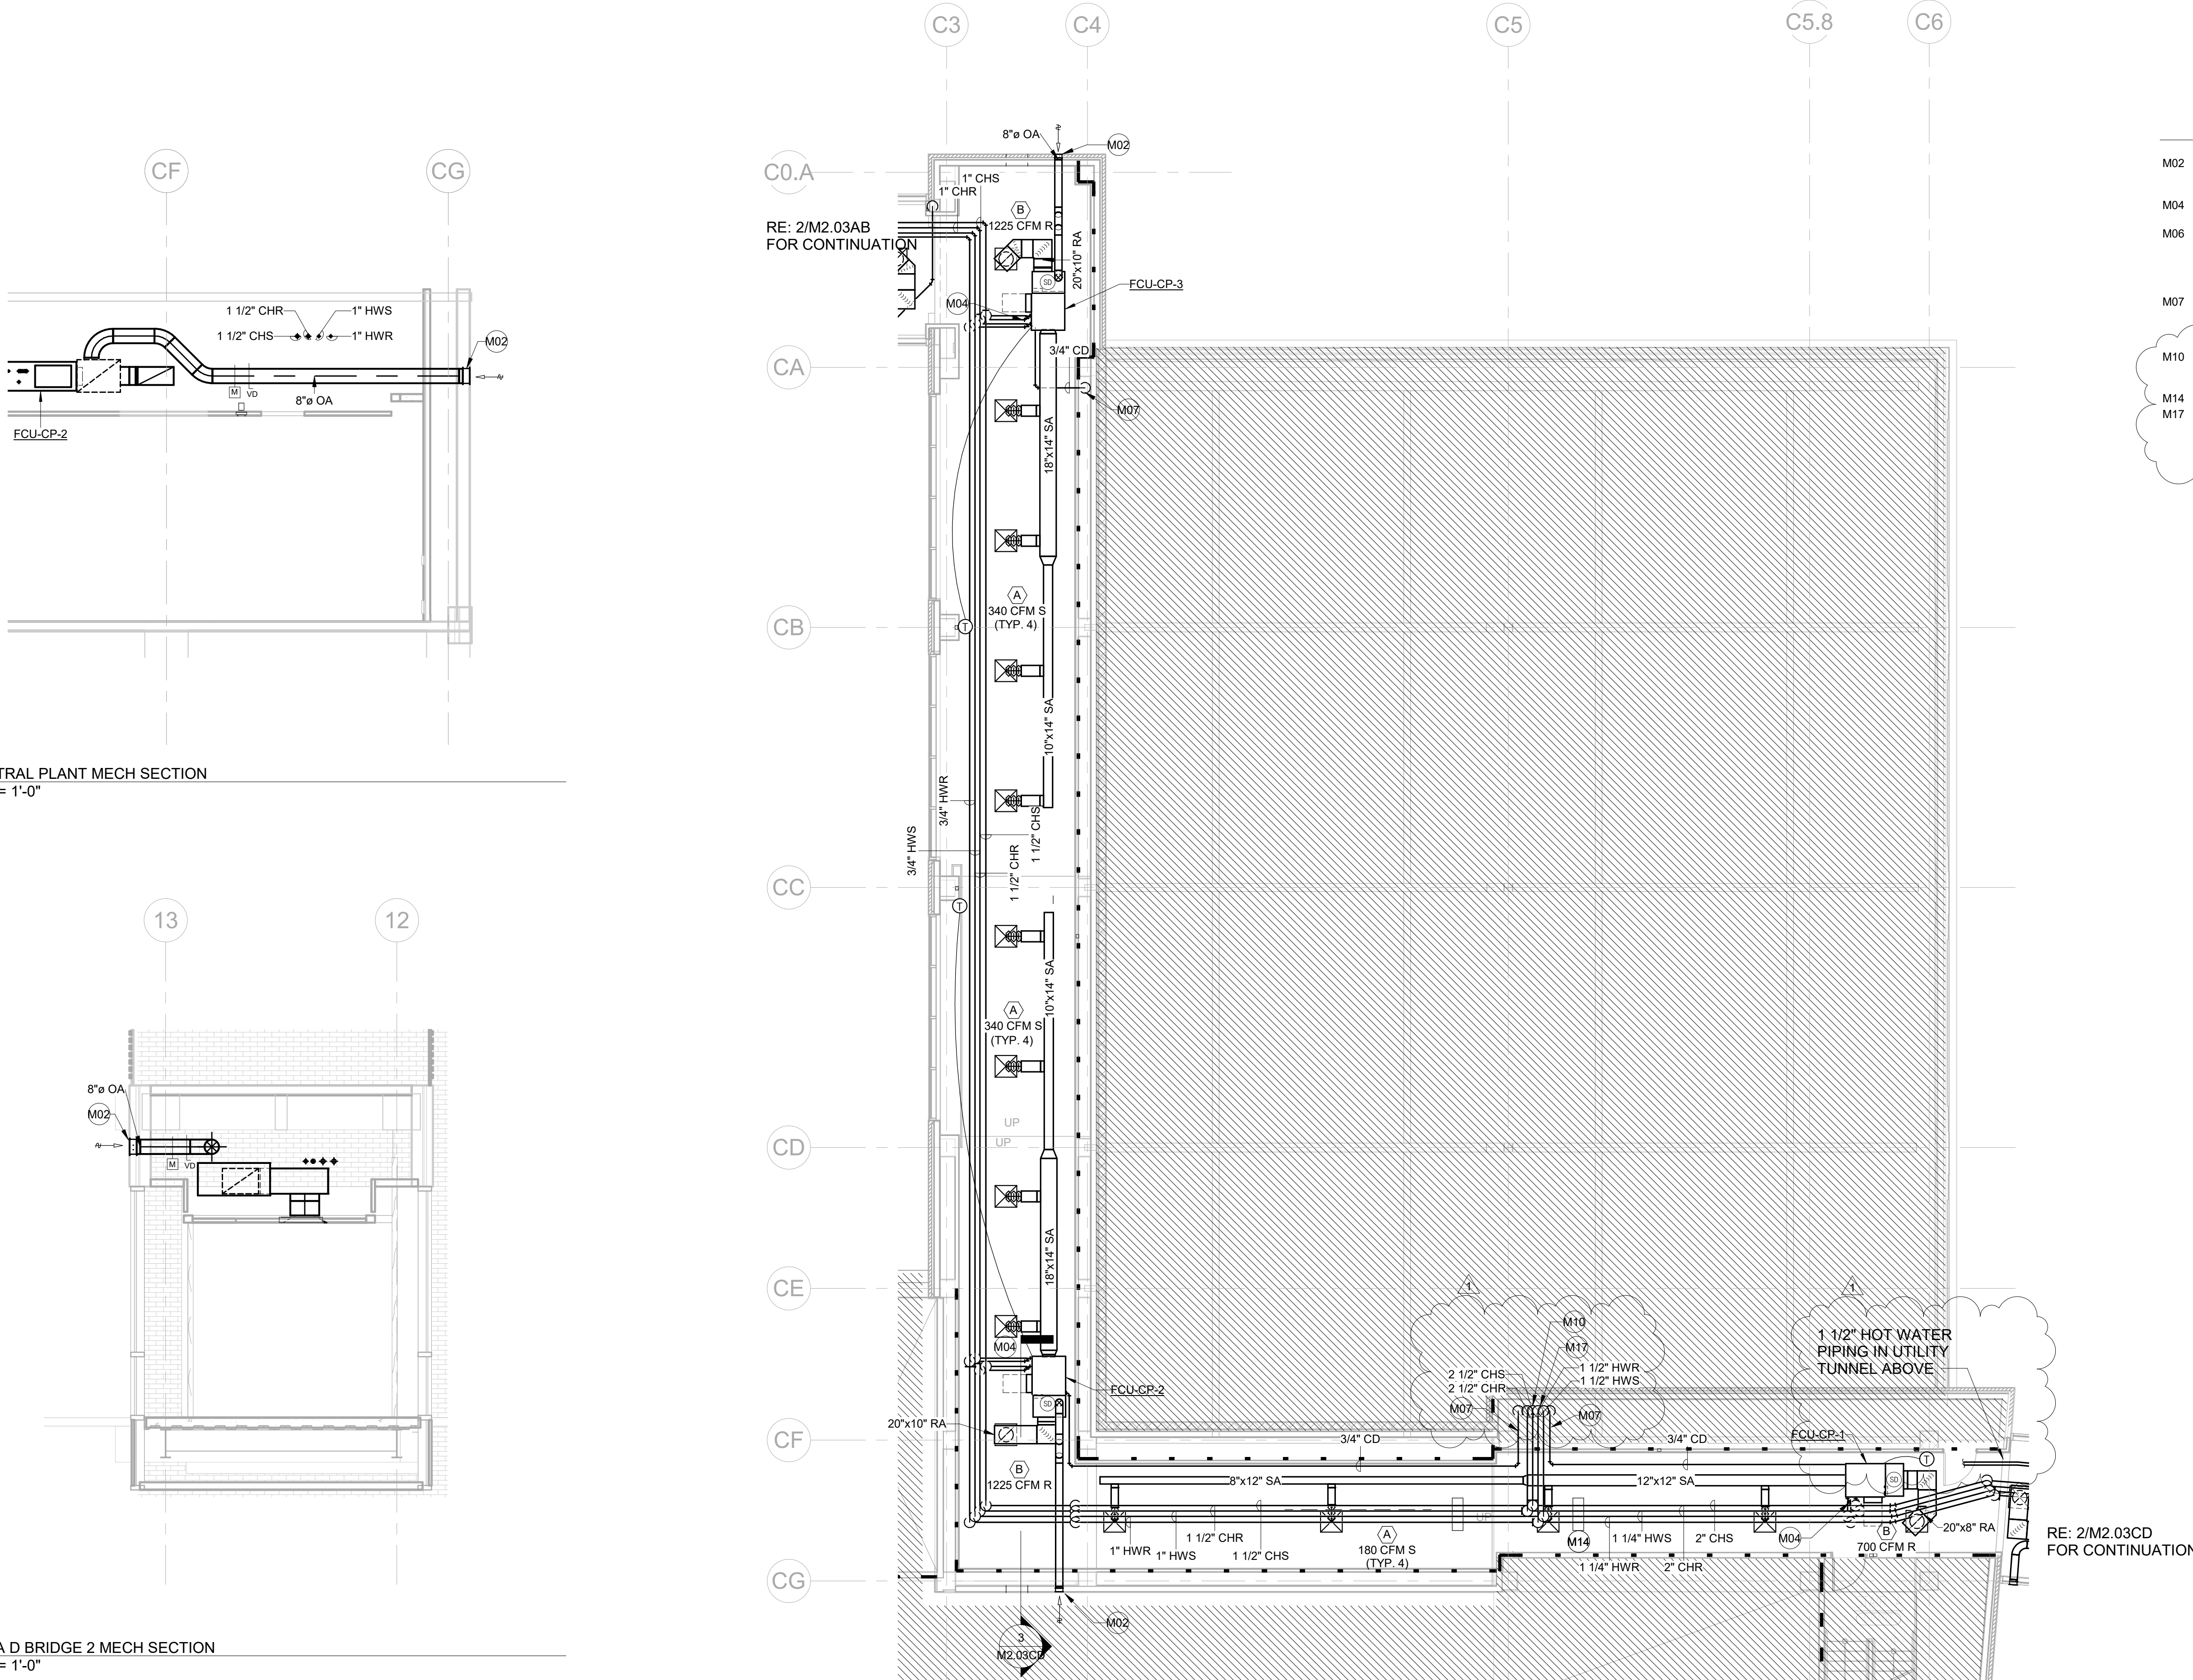


1 MECHANICAL FLOOR PLAN - LEVEL 3 - AREA C-CENTRAL PLANT  
1/8" = 1'-0"

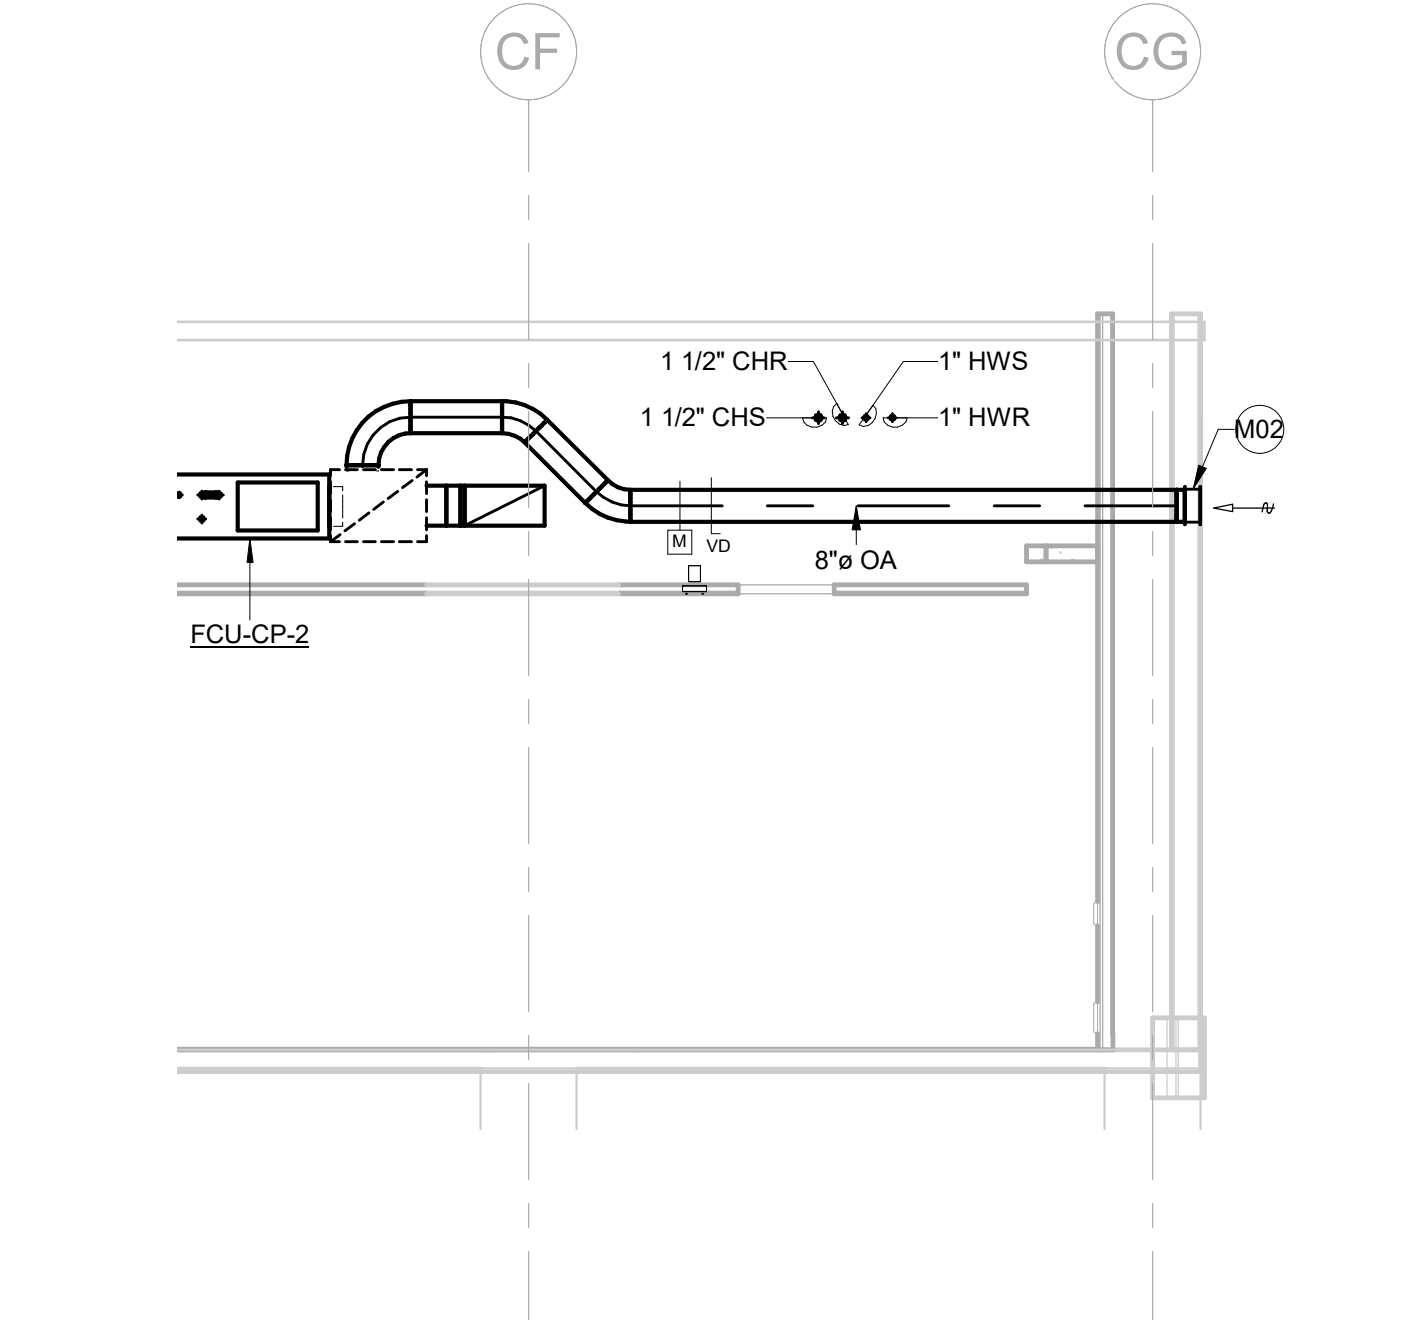

3 CENTRAL PLANT MECH SECTION  
1/4" = 1'-0"

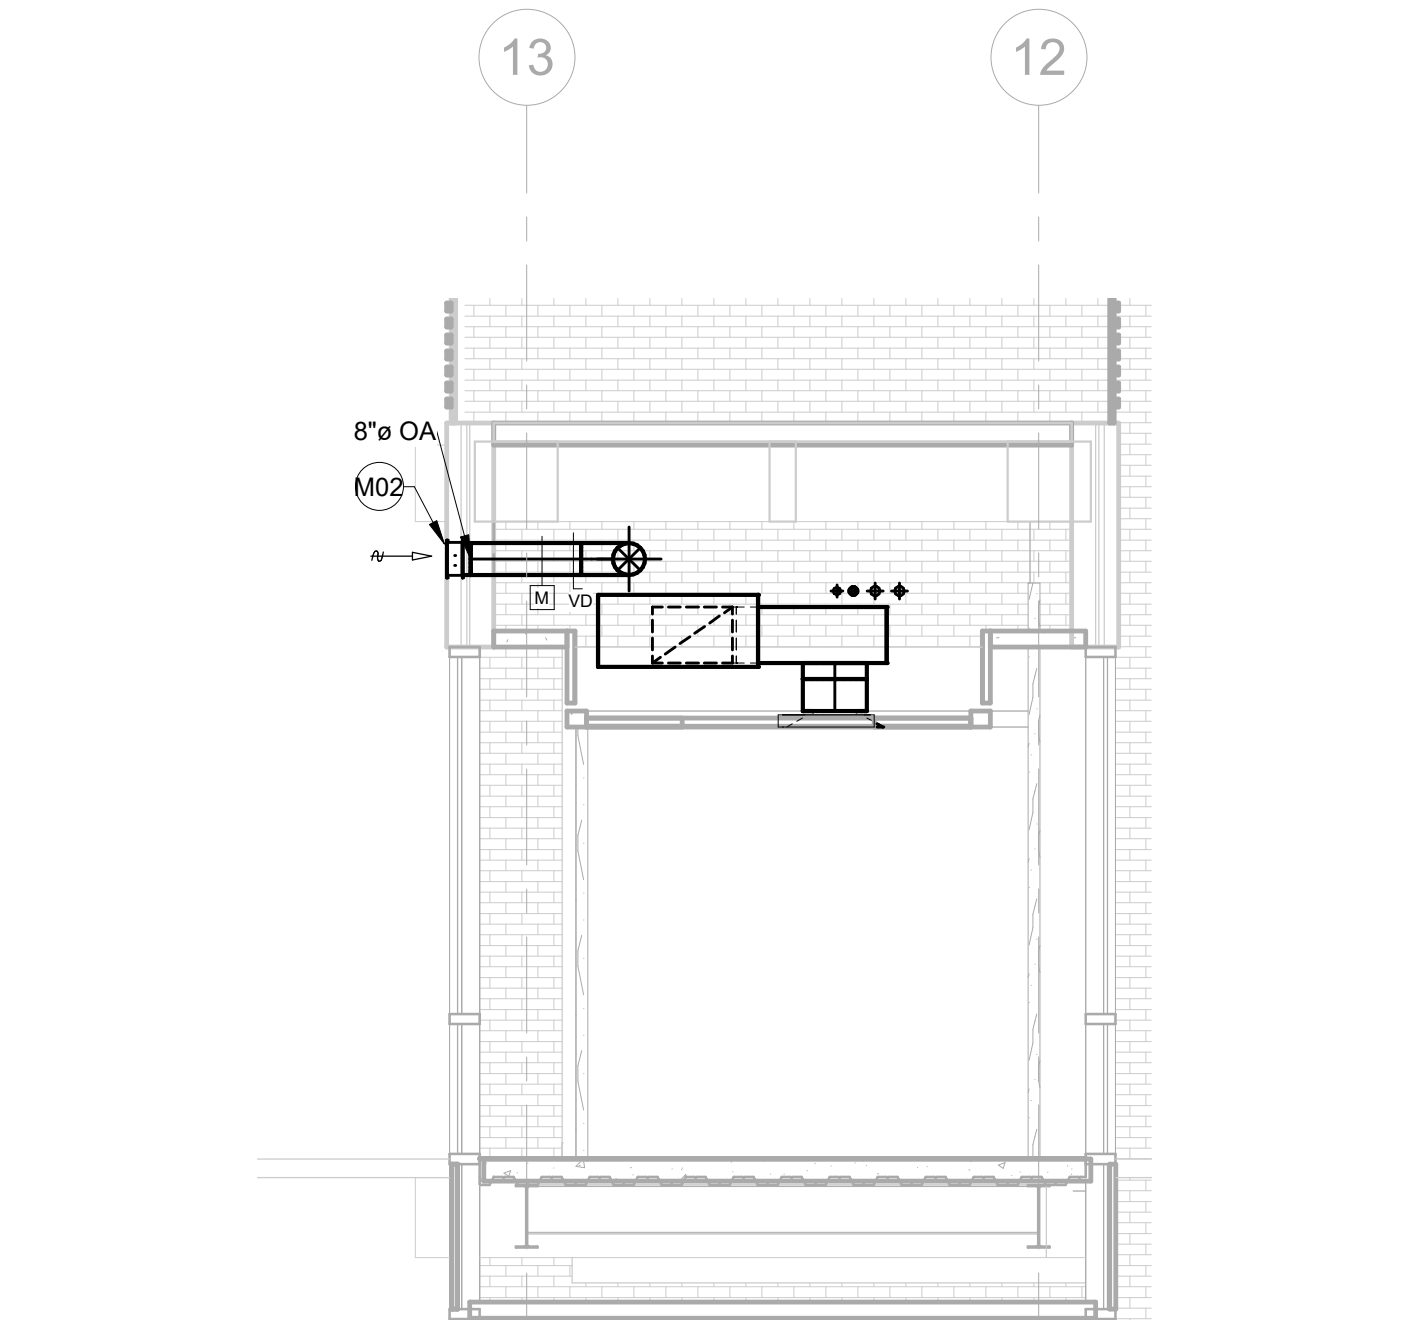

4 AREA D BRIDGE 2 MECH SECTION  
1/4" = 1'-0"

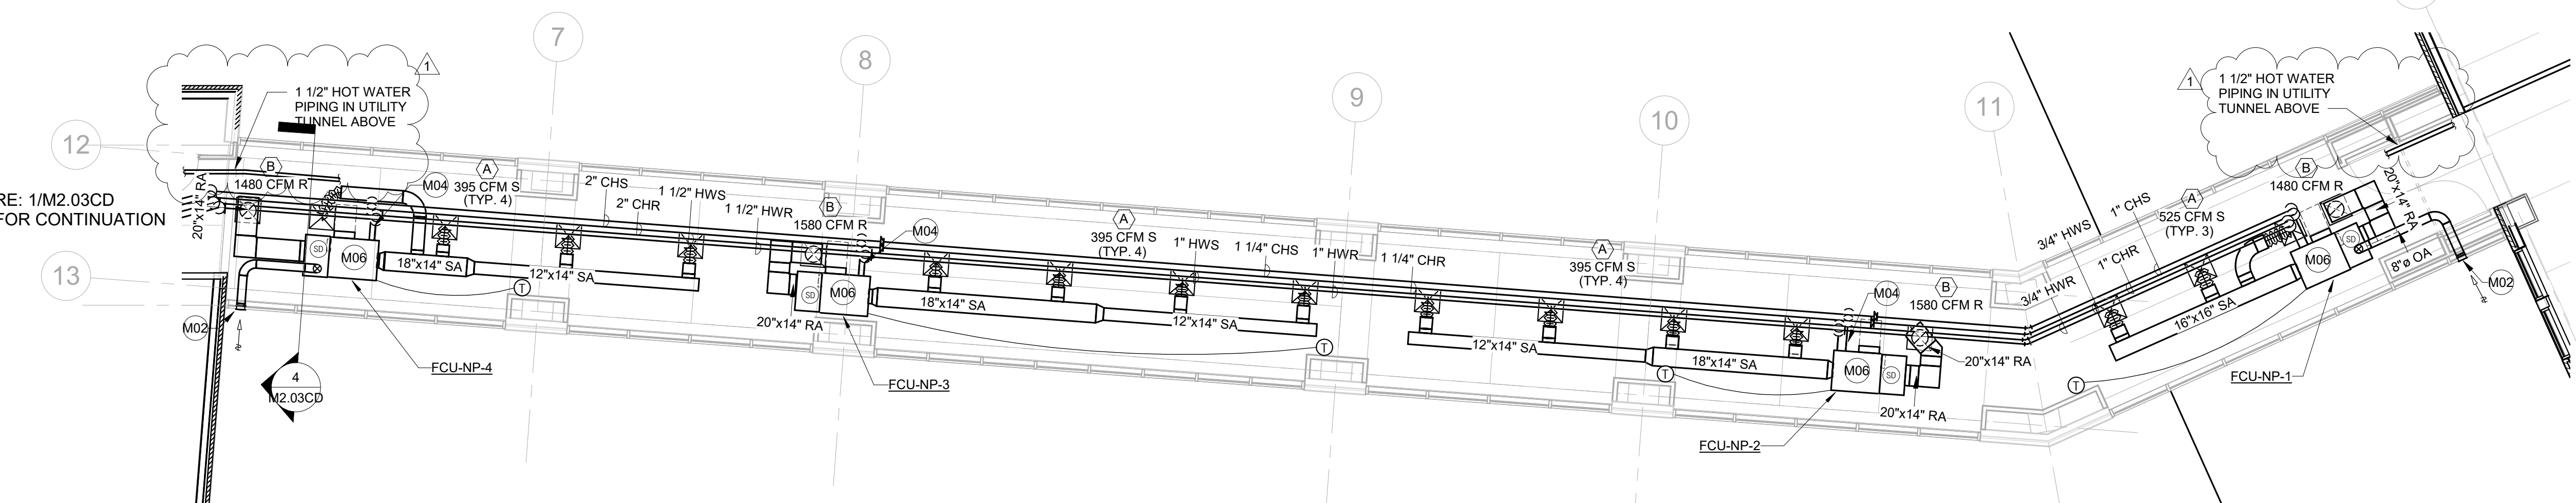

2 MECHANICAL FLOOR PLAN - LEVEL 3 - AREA D-BRIDGE 2  
1/8" = 1'-0"